
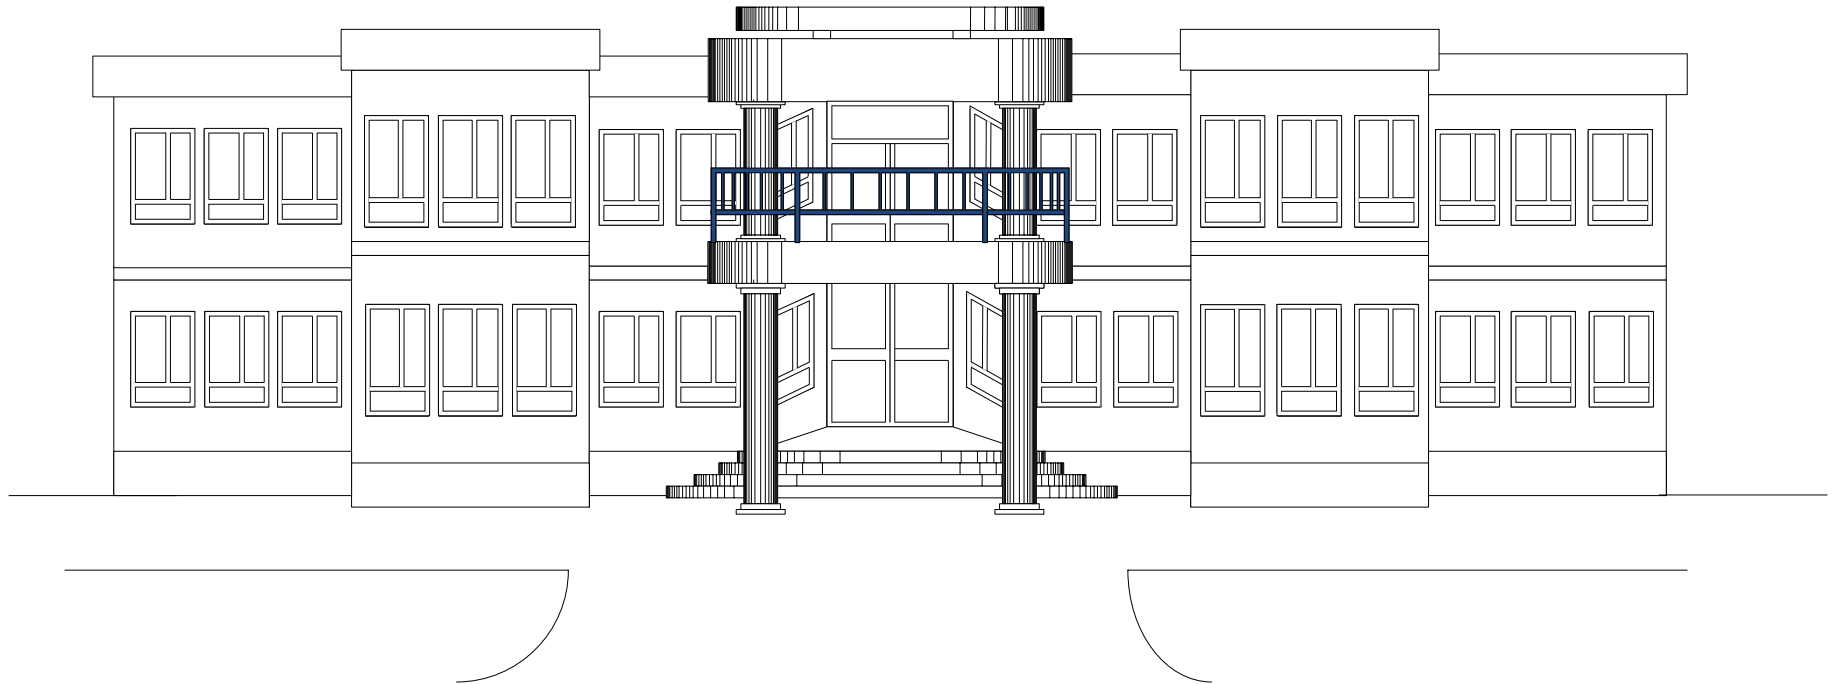


<b>AYENDA FUONDATION</b>		<b>Ayenda children learning center</b>		 <b>بنیاد بیات</b> <b>BAYAT FOUNDATION</b>
DESIGNED BY: ENG.M.ZAHIR SHIRZADA		<b>FLOOR PLAN</b>		
ENGINEERING DEPARTMENT		SUPERVISOR:	DISTRICT:	
APPROVED BY: ENG EHSANULLAH BAYAT		DATE:	AREA: 686M2	
			SCALE : 1:100	



**AYENDA FUONDATION**

DESIGNED BY: ENG.M.ZAHIR SHIRZADA

ENGINEERING DEPARTMENT

APPROVED BY: ENG EHSANULLAH BAYAT

**Ayenda children learning center**

**SOUTH VIEW**

SUPERVISOR:


DISTRICT:

DATE:

AREA:686M2

SCALE : 1:100



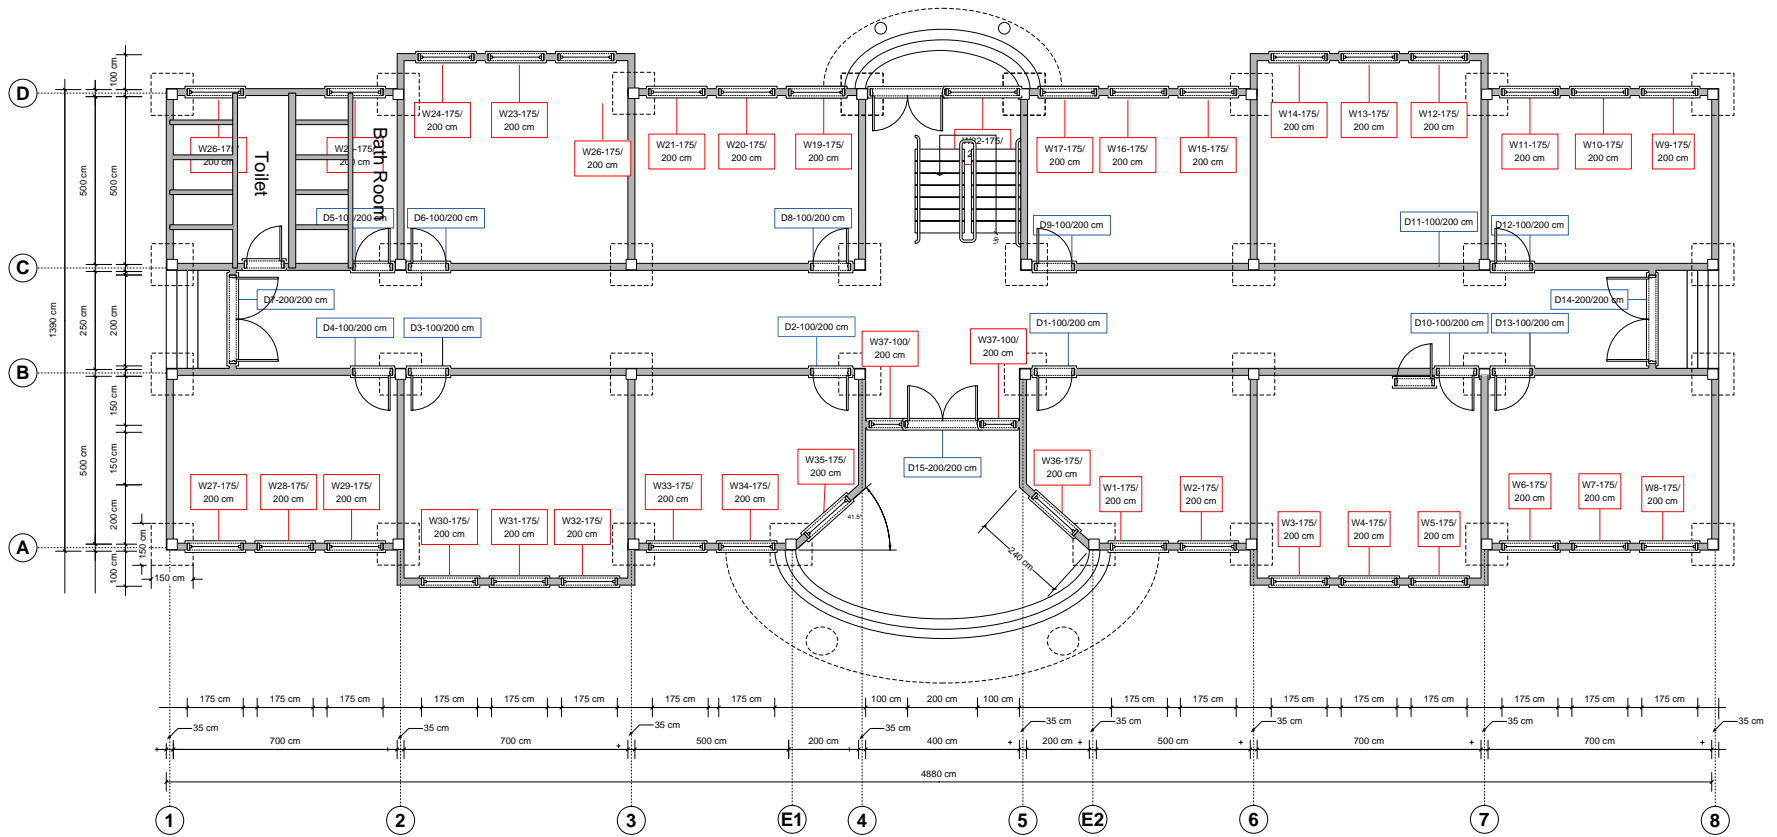

**AYENDA FUONDATION**

**Ayenda children learning center**

DESIGNED BY: ENG.M.ZAHIR SHIRZADA

**DOORS & WINDOWS PLAN**

ENGINEERING DEPARTMENT

APPROVED BY: ENG EHSANULLAH BAYAT

SUPERVISOR:


DISTRICT:

DATE:

AREA:686M2

SCALE : 1:100



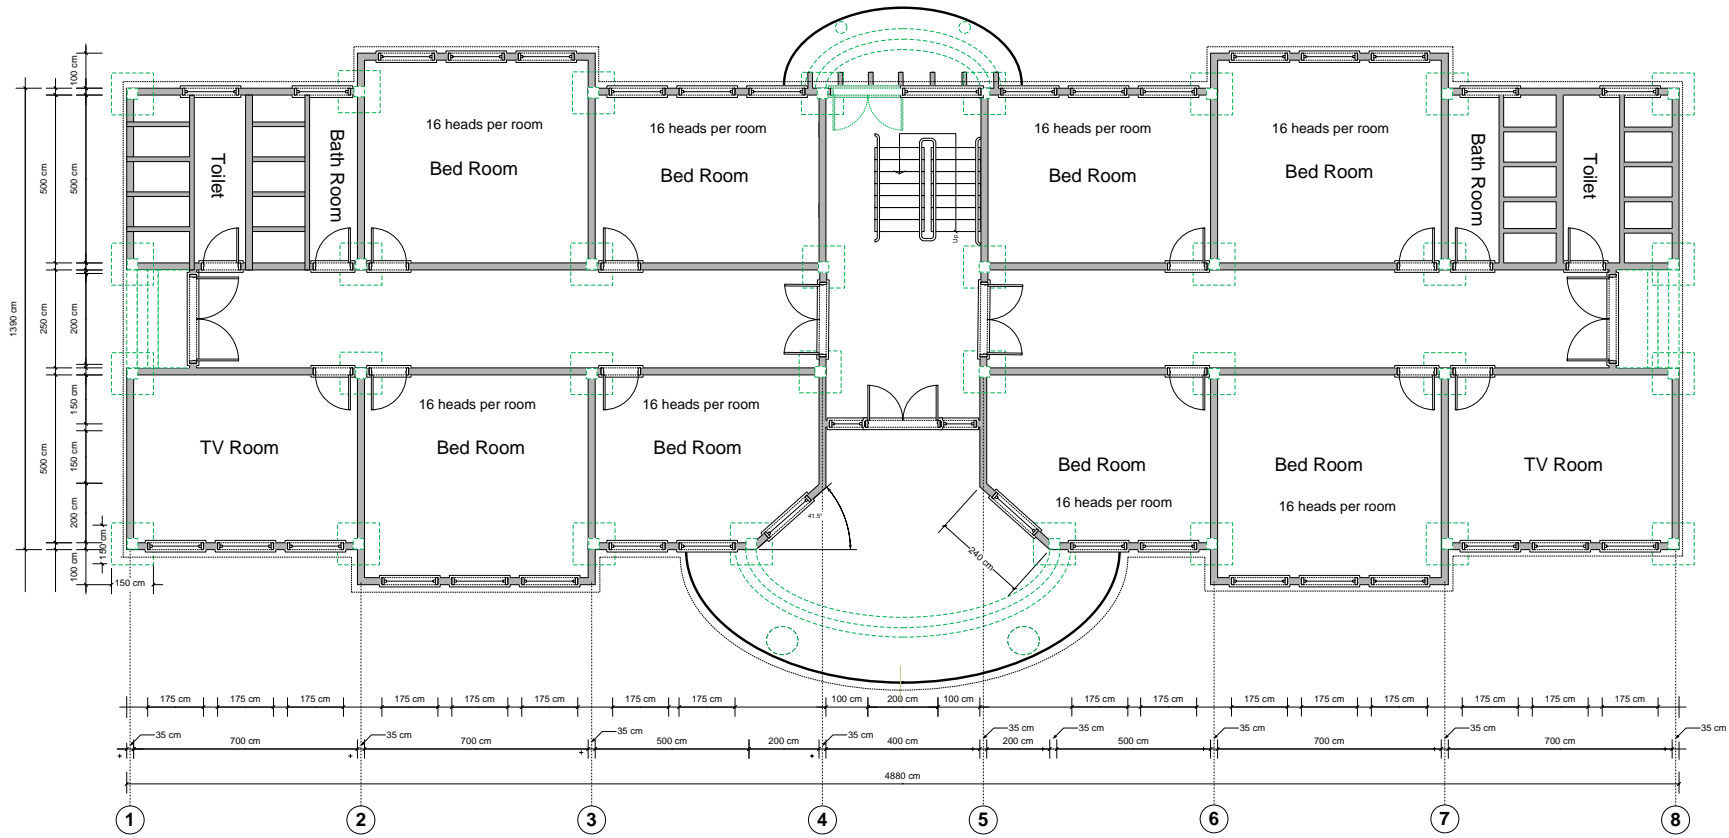

**AYENDA FUONDATION**

**Ayenda children learning center**

DESIGNED BY: ENG.M.ZAHIR SHIRZADA

**FIRST FLOOR**

ENGINEERING DEPARTMENT

APPROVED BY: ENG EHSANULLAH BAYAT

SUPERVISOR:


DISTRICT:

DATE:

AREA:686 M2

SCALE : 1:100



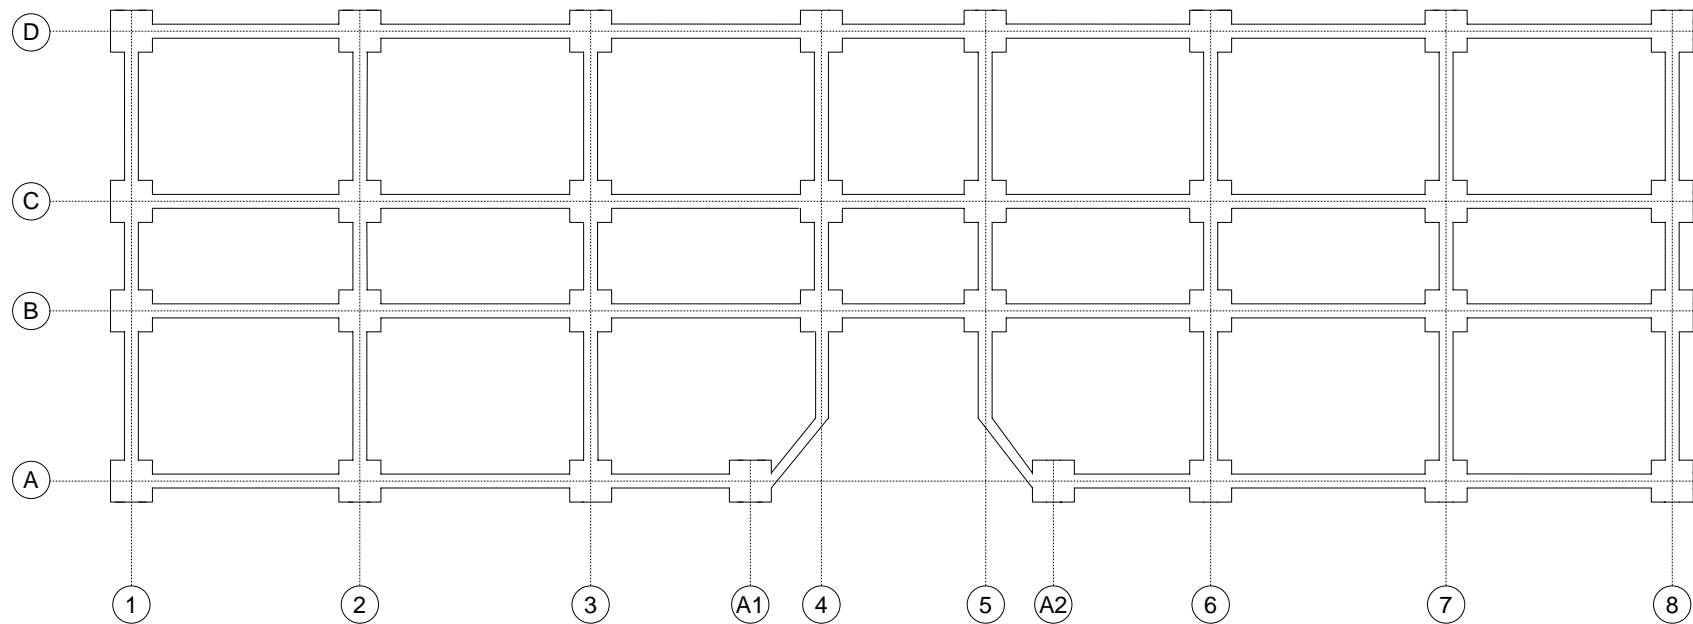

**AYENDA FUONDATION**

**Ayenda children learning center**

DESIGNED BY: ENG.M.ZAHIR SHIRZADA

**Foudation**

ENGINEERING DEPARTMENT

APPROVED BY: ENG EHSANULLAH BAYAT

SUPERVISOR:


DISTRICT:

DATE:

AREA:686 M2

SCALE : 1:100



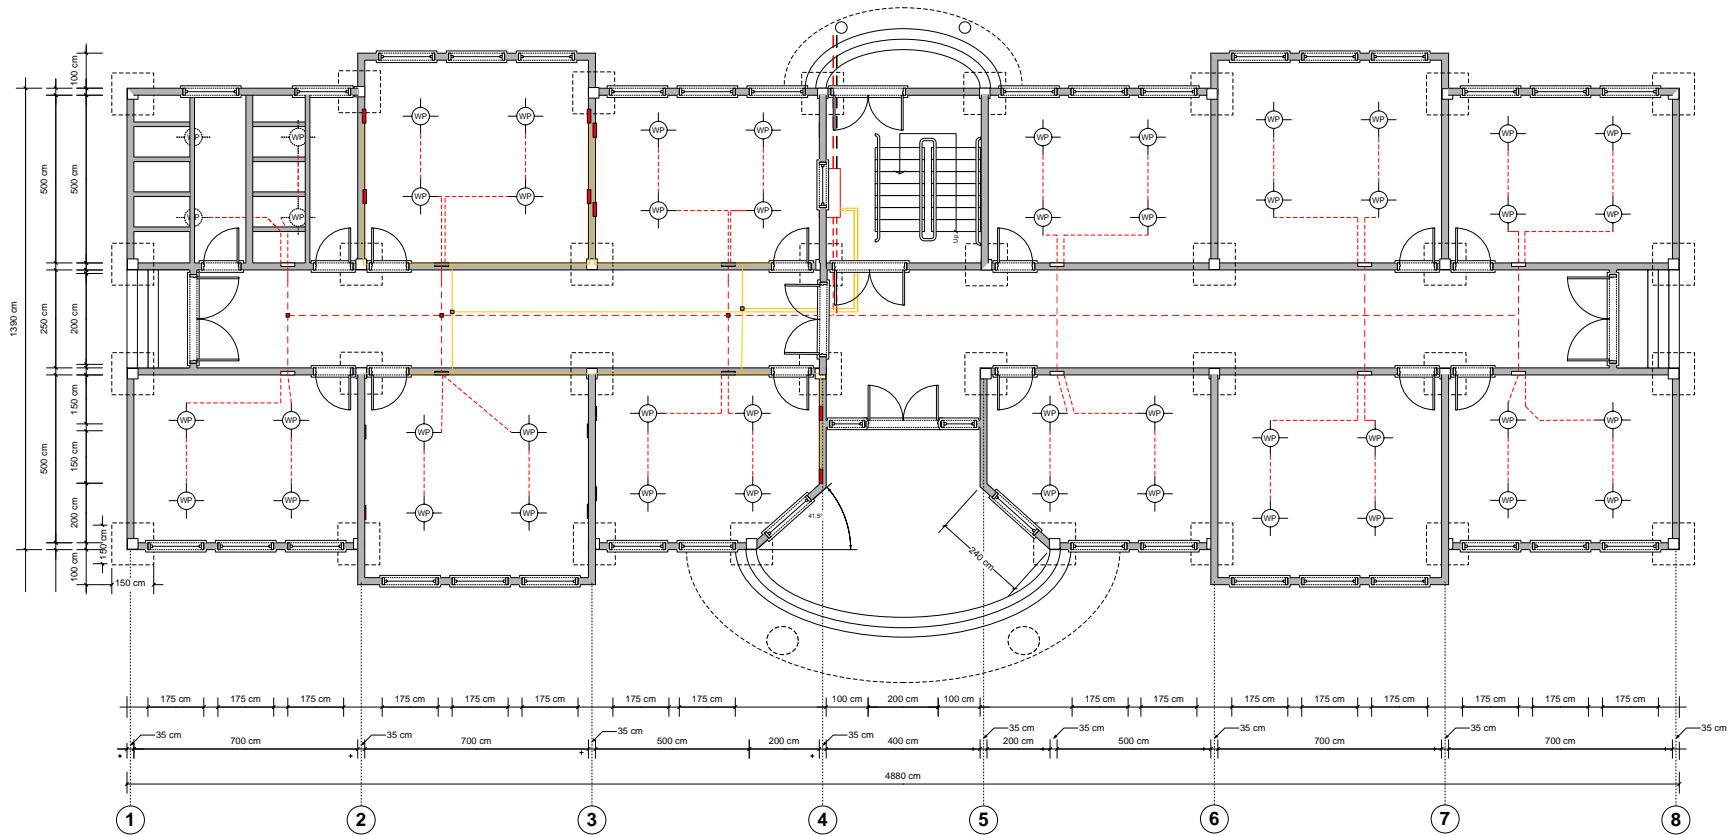

**AYENDA FUONDATION**

**Ayenda children learning center**

DESIGNED BY: ENG.M.ZAHIR SHIRZADA

**Ground floor electrical plan**

ENGINEERING DEPARTMENT

APPROVED BY: ENG EHSANULLAH BAYAT

SUPERVISOR:


DISTRICT:


DATE:


AREA: 686M2


SCALE : 1:100



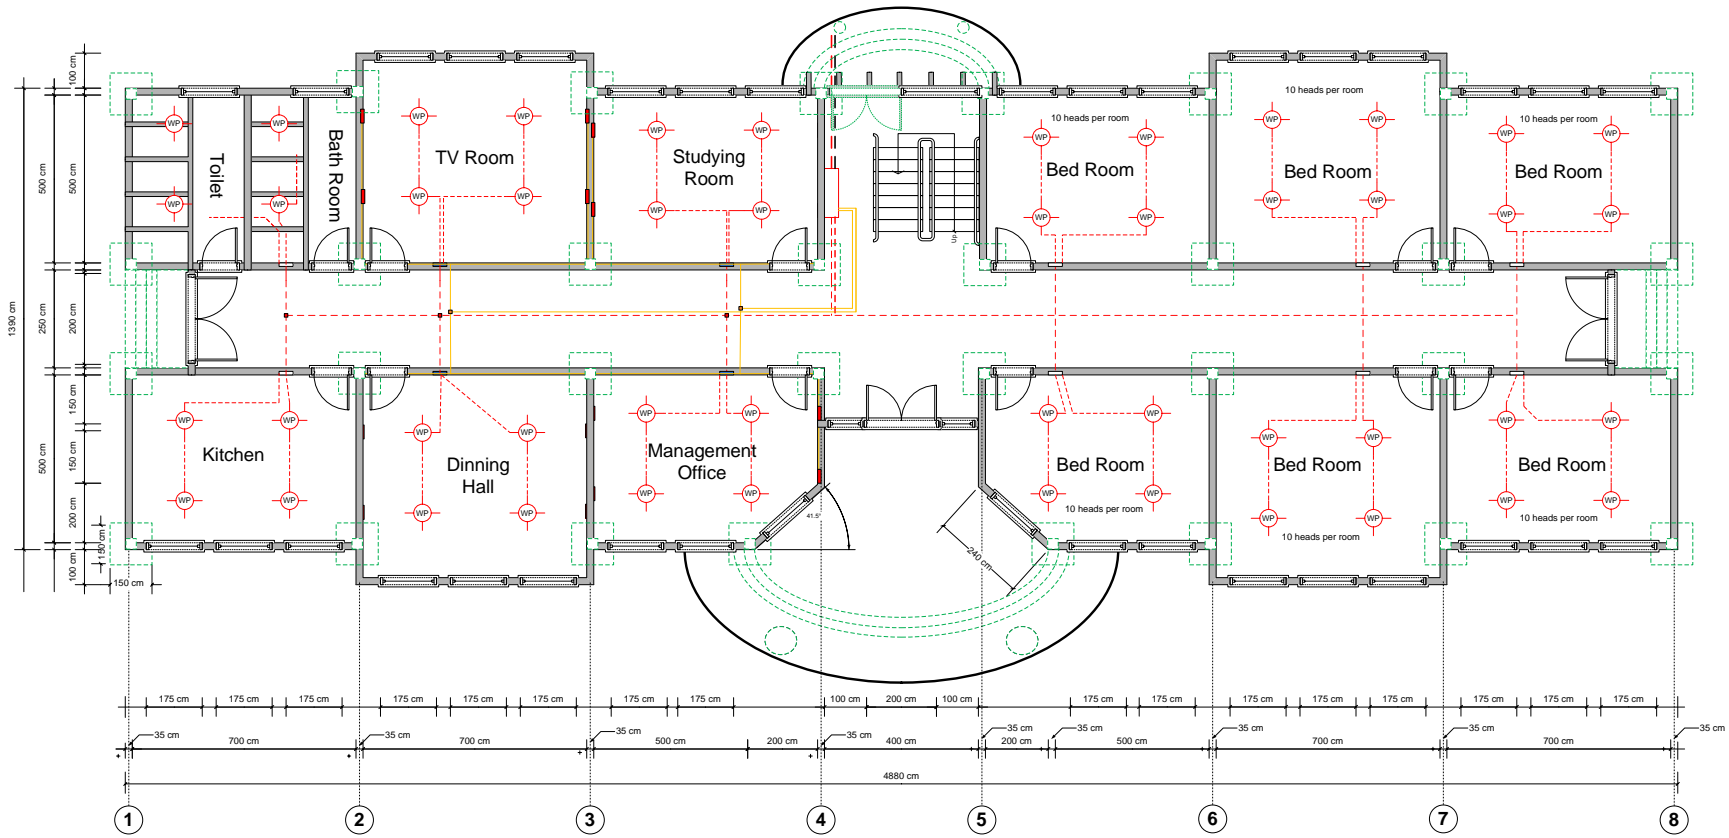

<b>AYENDA FUONDATION</b>		<b>Ayenda children learning center</b>		 <b>بنیاد بیات</b> <b>BAYAT FOUNDATION</b>
DESIGNED BY: ENG.M.ZAHIR SHIRZADA		<b>First floor electrical plan</b>		
ENGINEERING DEPARTMENT				
APPROVED BY: ENG EHSANULLAH BAYAT		SUPERVISOR:	DISTRICT:	
DATE:	AREA:686 M2	SCALE : 1:100		

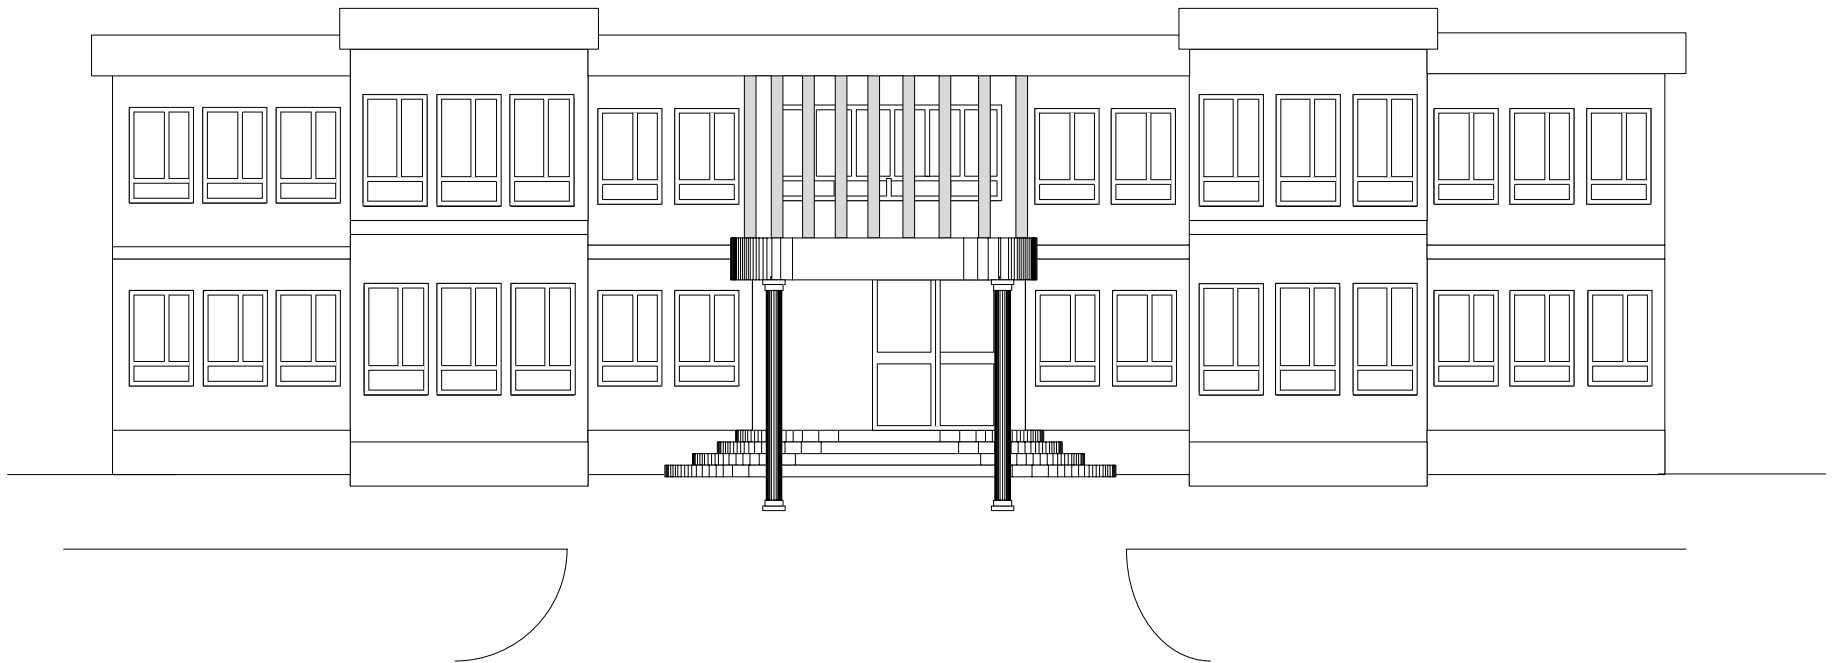

<b>AYENDA FUONDATION</b>	<b>Ayenda children learning center</b>			 <b>بنیاد بیات</b> <b>BAYAT FOUNDATION</b>
DESIGNED BY: ENG.M.ZAHIR SHIRZADA	<b>North view</b>			
ENGINEERING DEPARTMENT	SUPERVISOR:	DISTRICT:		
APPROVED BY: ENG EHSANULLAH BAYAT	DATE:	AREA:686M2	SCALE : 1:100	